
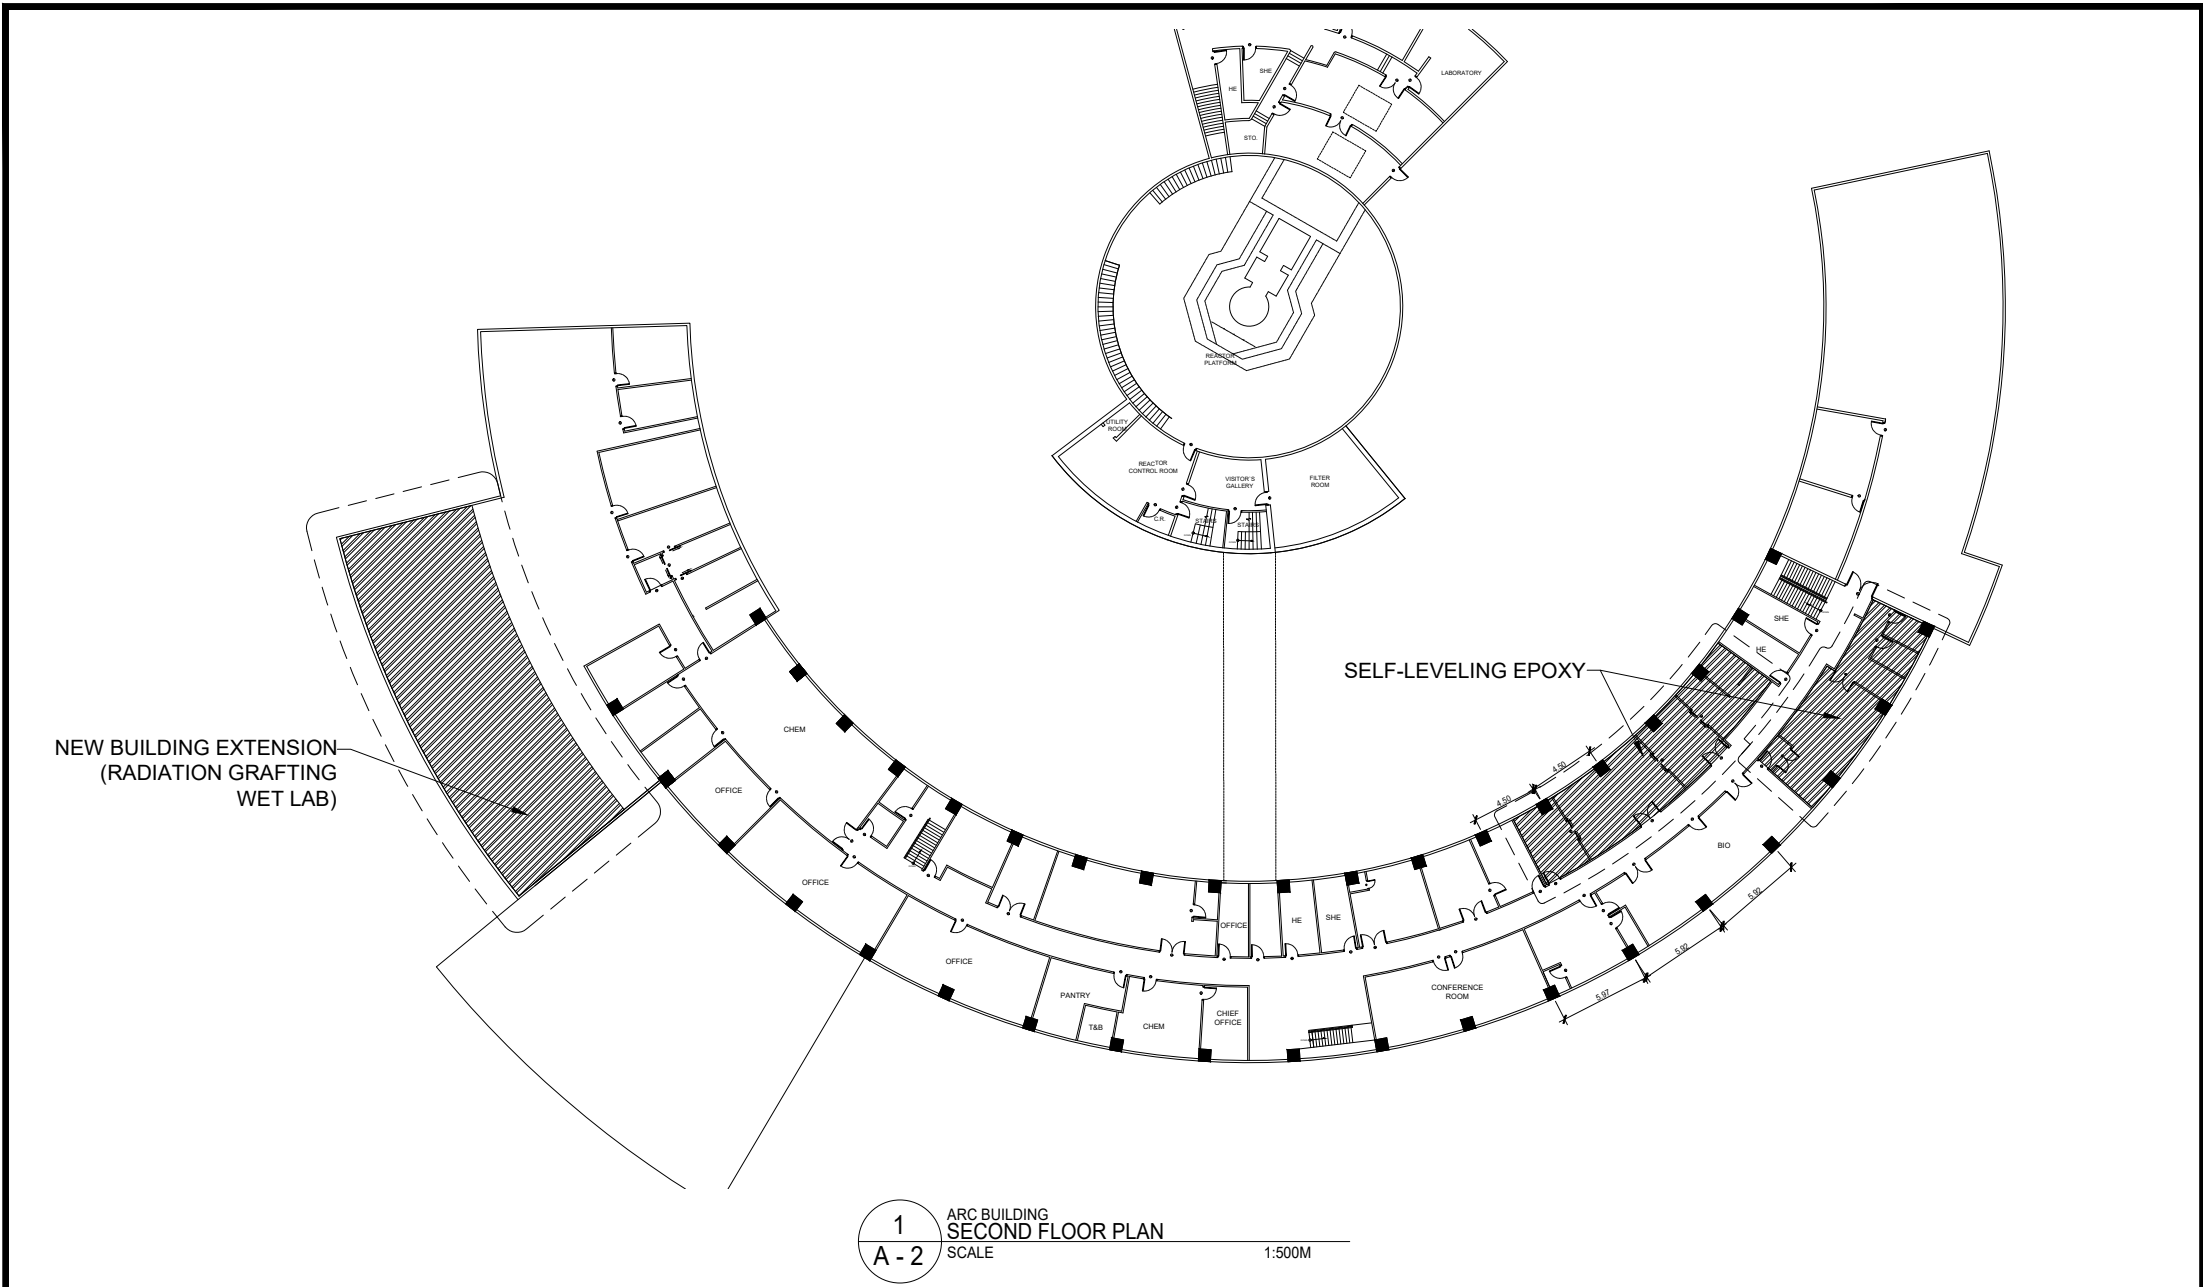
 



1 ARC BUILDING
 A - 1 SITE DEVELOPMENT PLAN
 SCALE NTS

 <p>Republic of the Philippines DEPARTMENT OF SCIENCE AND TECHNOLOGY PHILIPPINE NUCLEAR RESEARCH INSTITUTE COMMONWEALTH AVENUE, DILIMAN, QUEZON CITY</p>	PROJECT TITLE:	SHEET CONTENT/S:	PREPARED BY:	RECOMMENDING APPROVALS:	APPROVED BY:	DRAWN BY:	SHEET NO.
	UPGRADING OF ARC BUILDING (C.Y. 2023) (DESIGN AND BUILD)	ARC BUILDING SITE DEVELOPMENT PLAN	ENGR. ROSALINO B. REJAS SSRS, ESS ENGR. ANDREW C. BARRIDA ENGINEER II, ESS	JORDAN MADRID, Ph.D. END-USER, HEAD CRS LUCILLE V. ABAD, Ph.D. CHIEF, ARD PRECIOSA CORAZON B. PABROA, Ph. D. CHIEF, NSD	ENGR. ARTURO F. SALIH SSRS / OIC-ESS VALLERIE ANN I. SAMSON, Ph. D. DEPUTY DIRECTOR	ENGR. C. PELMONTE DATE:	A - 1
						CARLO A. ARCILLA, Ph. D. DIRECTOR	PAGE NO. OF TOTAL NO. OF PAGES
							01 of 16




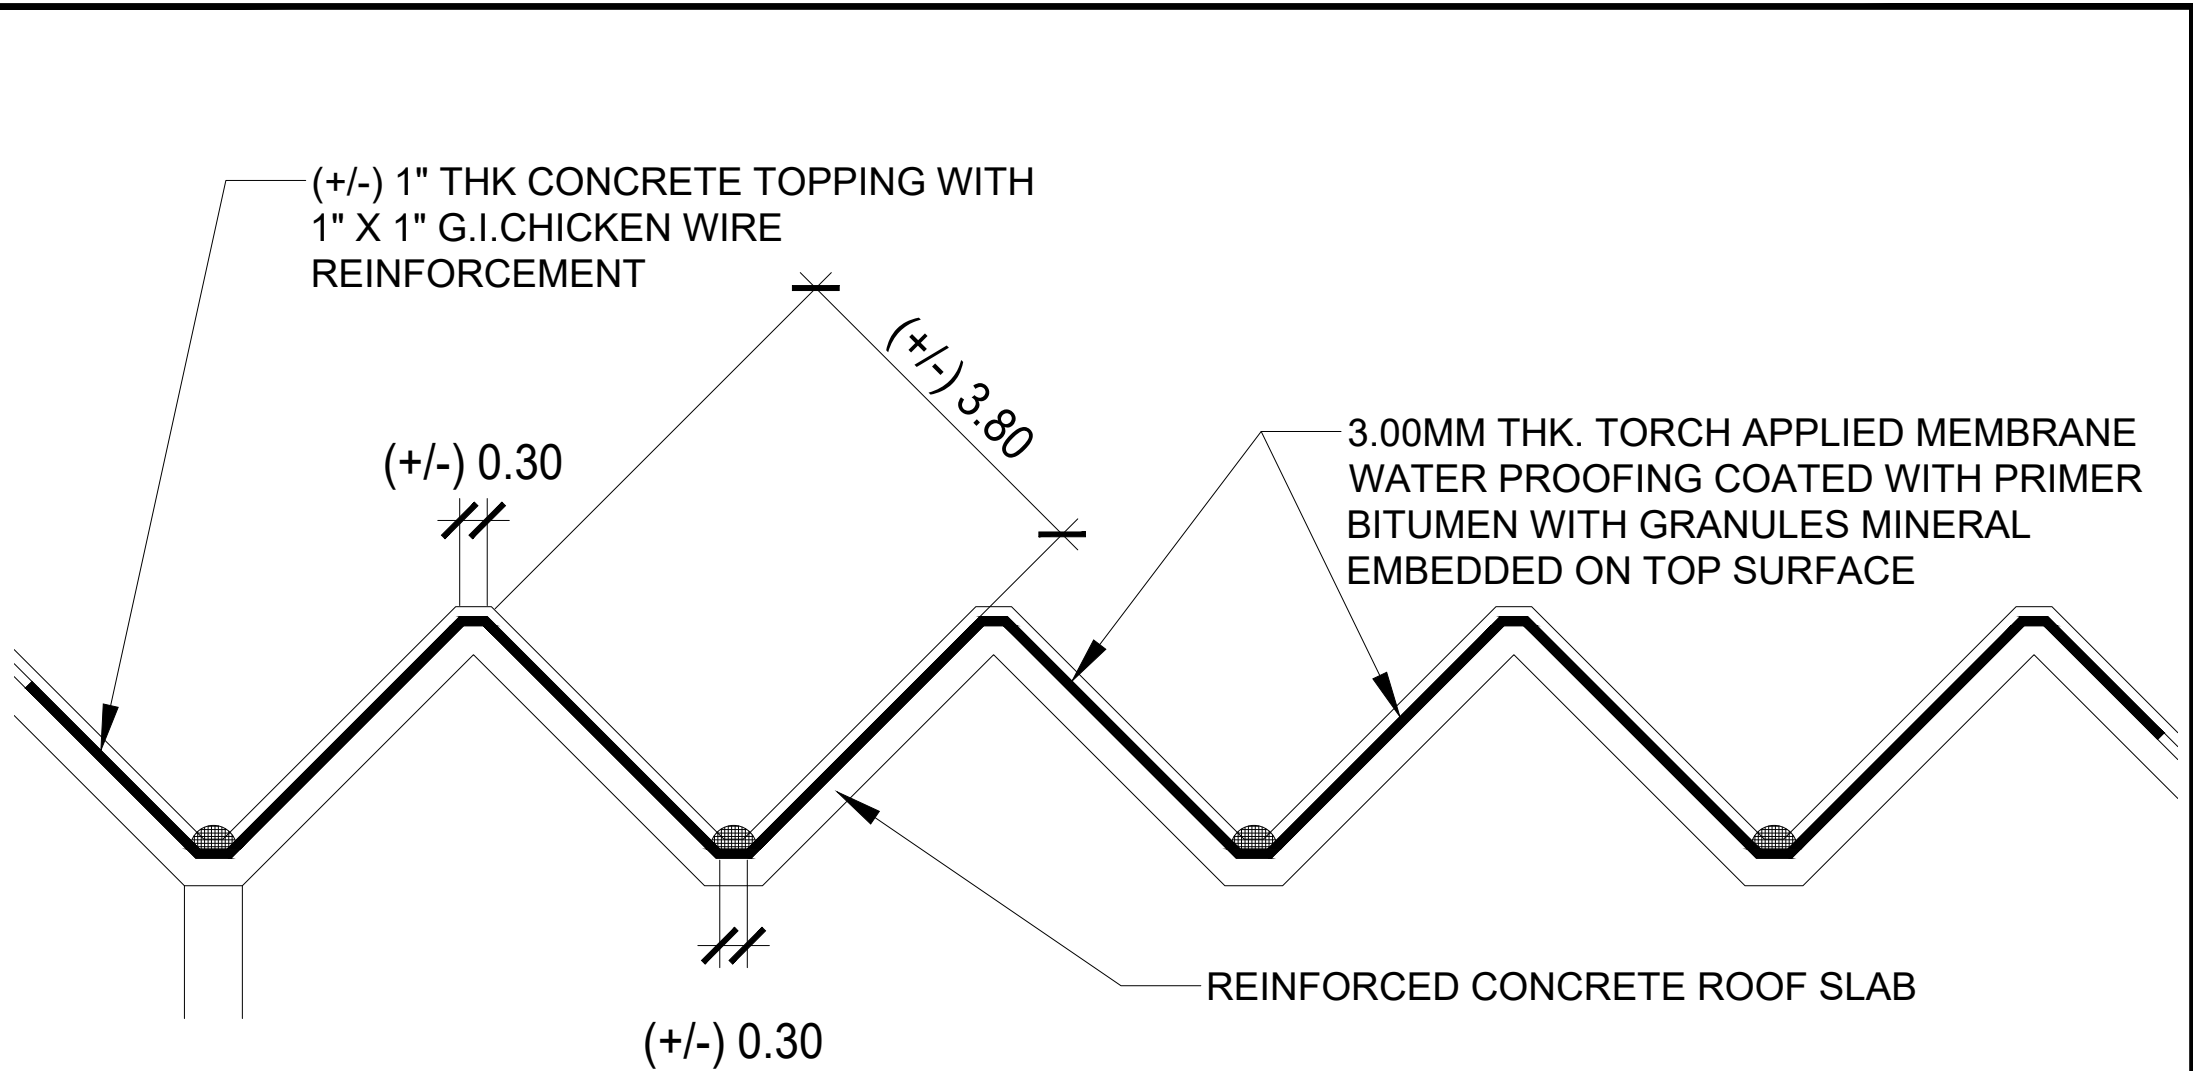
1 ARC BUILDING
 SECOND FLOOR PLAN
 A - 2 SCALE 1:500M

 <p>Republic of the Philippines DEPARTMENT OF SCIENCE AND TECHNOLOGY PHILIPPINE NUCLEAR RESEARCH INSTITUTE COMMONWEALTH AVENUE, DILIMAN, QUEZON CITY</p>	PROJECT TITLE:	SHEET CONTENT/S:	PREPARED BY:	RECOMMENDING APPROVALS:	APPROVED BY:	DRAWN BY:	SHEET NO.
	UPGRADING OF ARC BUILDING (C.Y. 2023) (DESIGN AND BUILD)	ARC BUILDING SECOND FLOOR PLAN	ENGR. ROSALINO B. REJAS SSRS, ESS ENGR. ANDREW C. BARRIDA ENGINEER II, ESS	JORDAN MADRID, Ph.D. END-USER, HEAD CRS LUCILLE V. ABAD, Ph.D. CHIEF, ARD PRECIOSA CORAZON B. PABROA, Ph. D. CHIEF, NSD	ENGR. ARTURO F. SALIH SSRS / OIC-ESS VALLERIE ANN I. SAMSON, Ph. D. DEPUTY DIRECTOR	ENGR. C. PELMONTE DATE:	A - 2
						CARLO A. ARCILLA, Ph. D. DIRECTOR	PAGE NO. OF TOTAL NO. OF PAGES 02 of 16

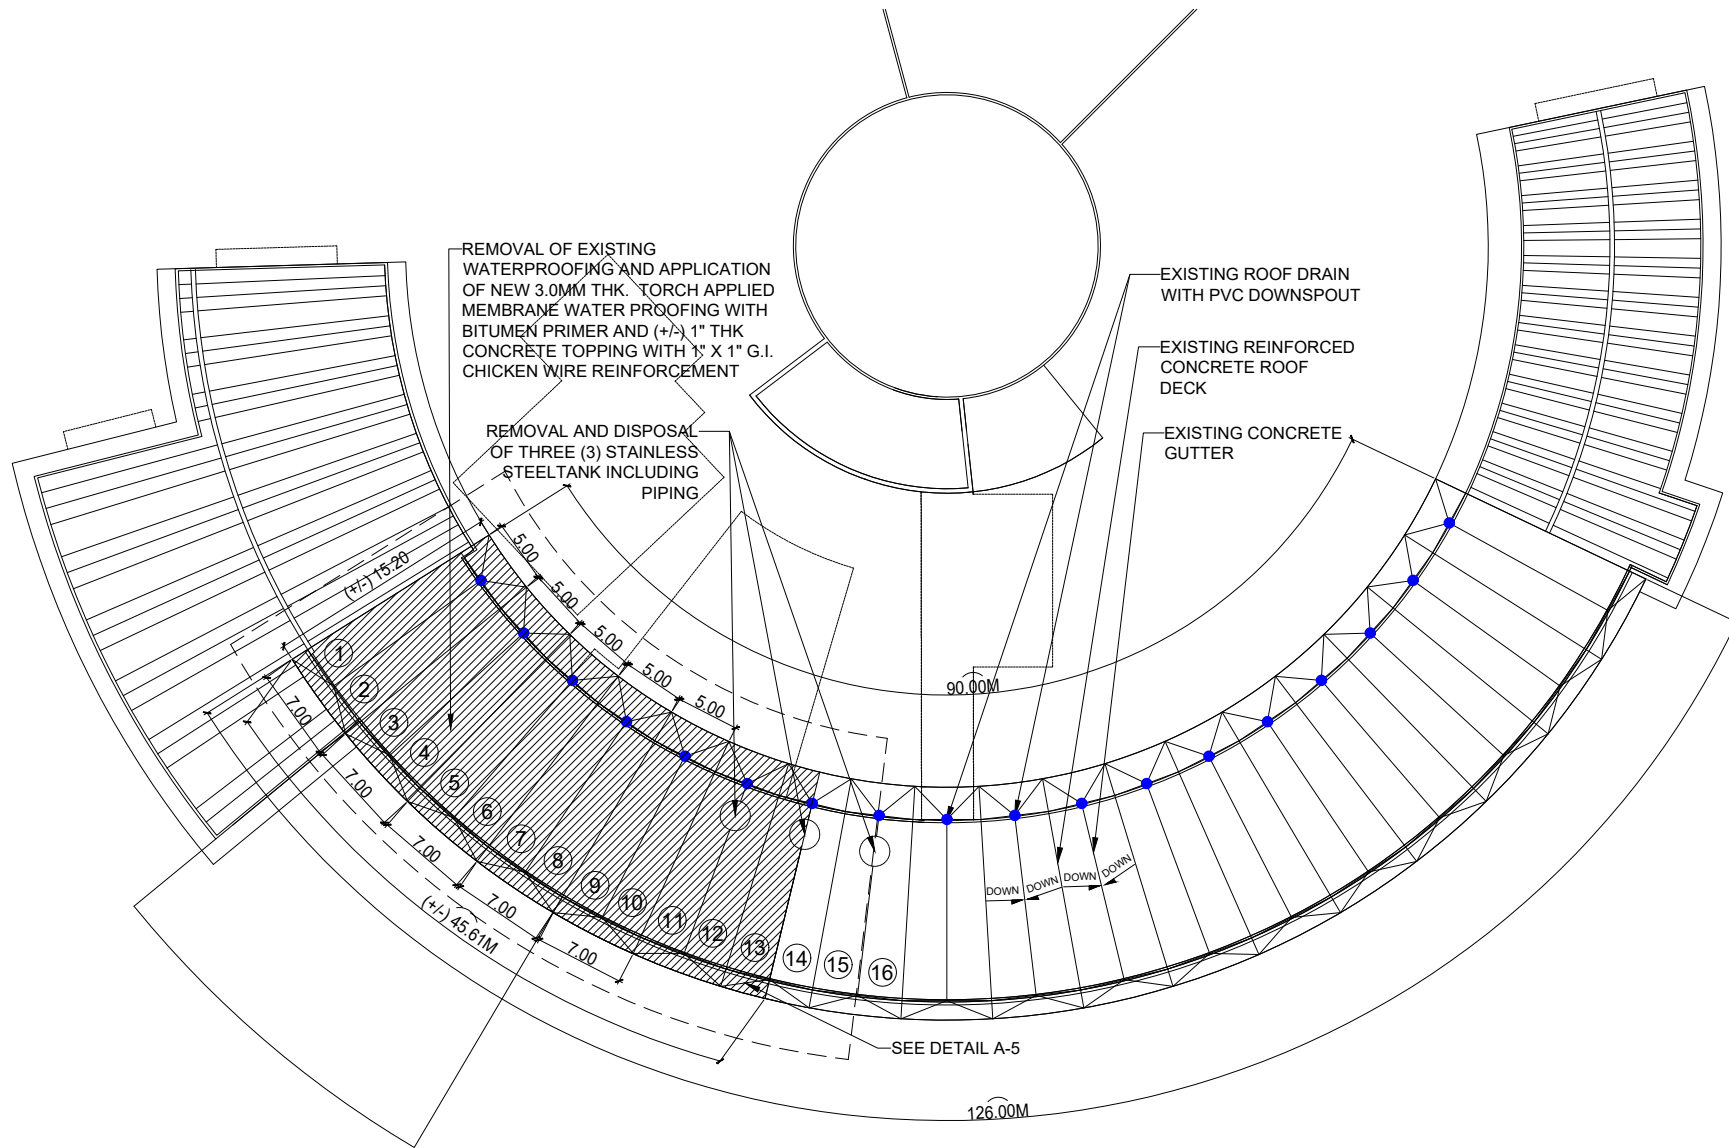


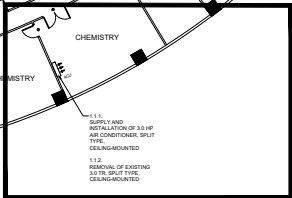
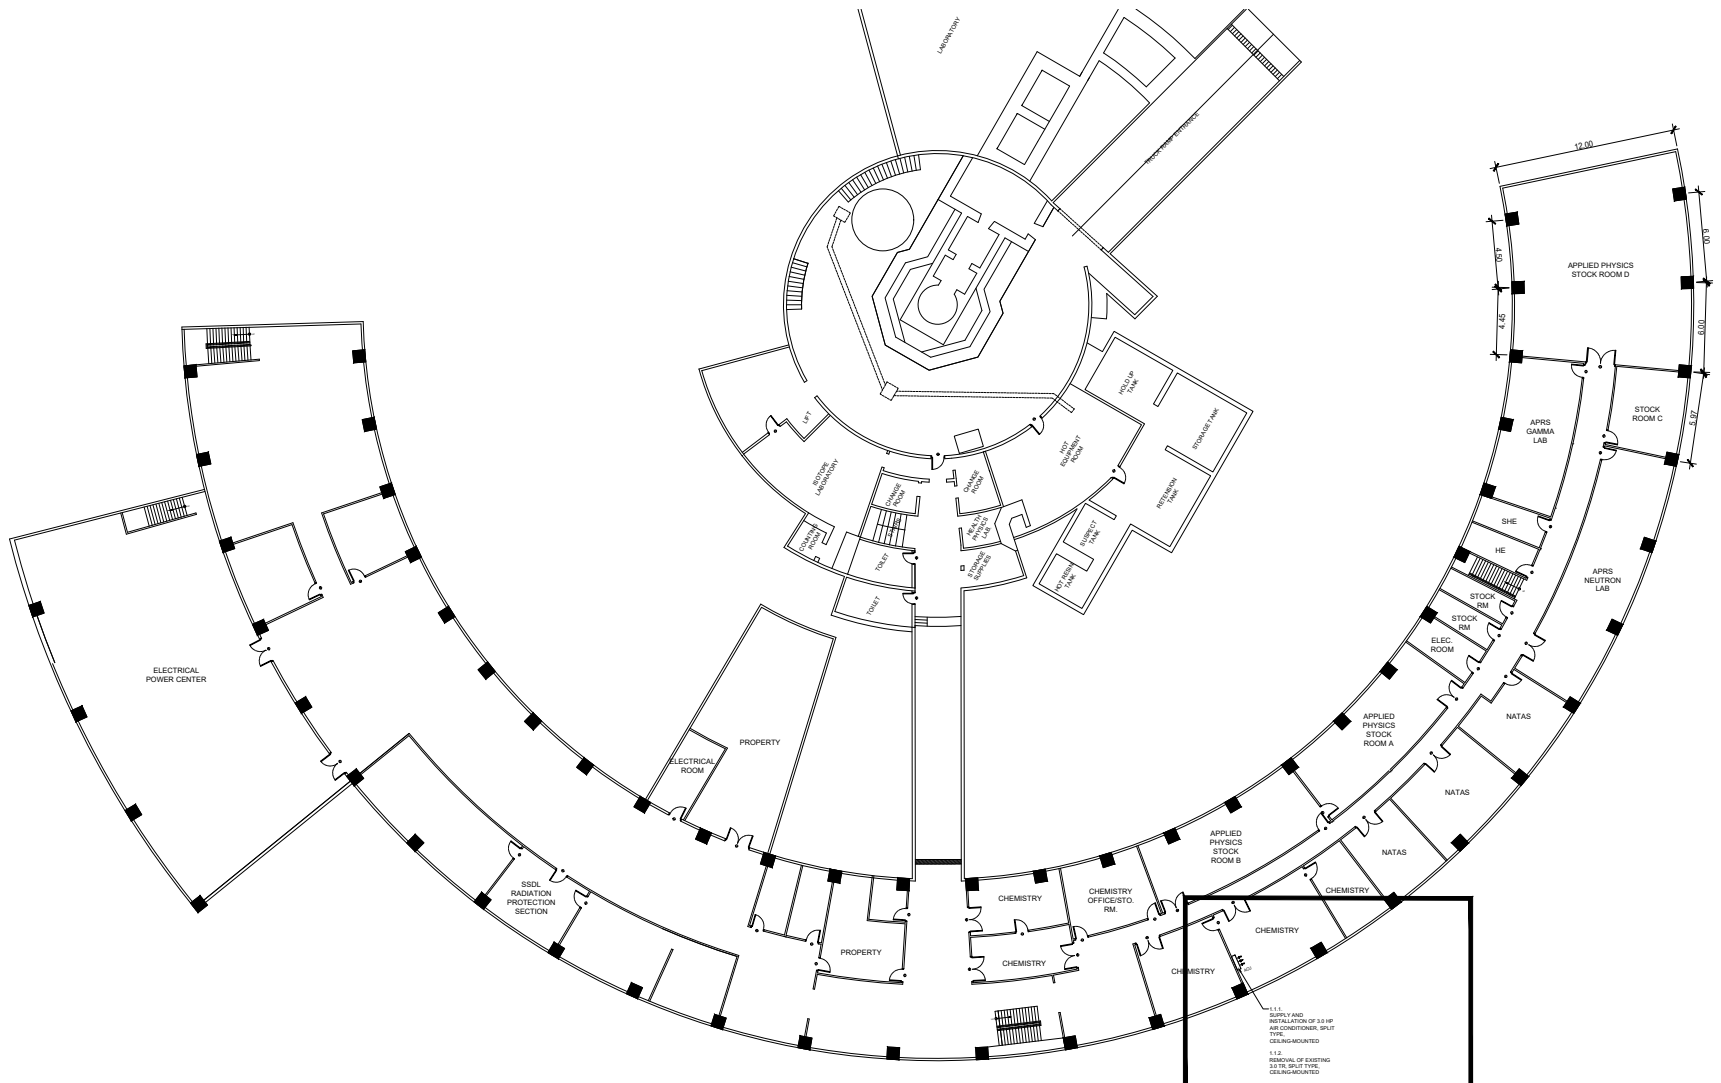
1 ARC BUILDING
 ROOF FRAMING PLAN
 A - 5 SCALE NTS

 <p>Republic of the Philippines DEPARTMENT OF SCIENCE AND TECHNOLOGY PHILIPPINE NUCLEAR RESEARCH INSTITUTE COMMONWEALTH AVENUE, DILIMAN, QUEZON CITY</p>	PROJECT TITLE:	SHEET CONTENT/S:	PREPARED BY:	RECOMMENDING APPROVALS:	APPROVED BY:	DRAWN BY:	SHEET NO.
	UPGRADING OF ARC BUILDING (C.Y. 2023) (DESIGN AND BUILD)	ARC BUILDING ROOF FRAMING PLAN	ENGR. ROSALINO B. REJAS SSRS, ESS ENGR. ANDREW C. BARRIDA ENGINEER II, ESS	JORDAN MADRID, Ph.D. END-USER, HEAD CRS LUCILLE V. ABAD, Ph.D. CHIEF, ARD PRECIOSA CORAZON B. PABROA, Ph. D. CHIEF, NSD	ENGR. ARTURO F. SALIH SSRS / OIC-ESS VALLERIE ANN I. SAMSON, Ph. D. DEPUTY DIRECTOR	ENGR. C. PELMONTE DATE:	A - 5
						CARLO A. ARCILLA, Ph. D. DIRECTOR	PAGE NO. OF TOTAL NO. OF PAGES 06 of 16




1 ARC BUILDING
SECTION DETAIL OF ROOFING
A - 6 SCALE NTS


 <p>Republic of the Philippines DEPARTMENT OF SCIENCE AND TECHNOLOGY PHILIPPINE NUCLEAR RESEARCH INSTITUTE COMMONWEALTH AVENUE, DILIMAN, QUEZON CITY</p>	PROJECT TITLE:	SHEET CONTENT/S:	PREPARED BY:	RECOMMENDING APPROVALS:	APPROVED BY:	DRAWN BY:	SHEET NO.
	UPGRADING OF ARC BUILDING (C.Y. 2023) (DESIGN AND BUILD)	ARC BUILDING SECTION DETAIL OF ROOFING	ENGR. ROSALINO B. REJAS SSRS, ESS ENGR. ANDREW C. BARRIDA ENGINEER II, ESS	JORDAN MADRID, Ph.D. END-USER, HEAD CRS LUCILLE V. ABAD, Ph.D. CHIEF, ARD PRECIOSA CORAZON B. PABROA, Ph. D. CHIEF, NSD	ENGR. ARTURO F. SALIH SSRS / OIC-ESS VALLERIE ANN I. SAMSON, Ph. D. DEPUTY DIRECTOR	ENGR. C. PELMONTE DATE:	A - 6
					CARLO A. ARCILLA, Ph. D. DIRECTOR		PAGE NO. OF TOTAL NO. OF PAGES 07 of 16




SEE BLOW-UP DETAIL @ M - 4

1 BASEMENT
M - 1 LOCATION OF AIR CONDITION UNIT
SCALE 1:500


 Republic of the Philippines DEPARTMENT OF SCIENCE AND TECHNOLOGY PHILIPPINE NUCLEAR RESEARCH INSTITUTE COMMONWEALTH AVENUE, DILIMAN, QUEZON CITY	PROJECT TITLE:	SHEET CONTENT/S:	PREPARED BY:	RECOMMENDING APPROVALS:	APPROVED BY:	DRAWN BY:	SHEET NO.
	UPGRADING OF ARC BUILDING (C.Y. 2023) (DESIGN AND BUILD)	BASEMENT LOCATION OF AIR CONDITION UNIT	<u>ENGR. ROSALINO B. REJAS</u> <small>SSRS, ESS</small> <u>ENGR. ANDREW C. BARRIDA</u> <small>ENGINEER II, ESS</small>	<u>JORDAN MADRID, Ph.D.</u> <small>END-USER, HEAD CBS</small> <u>LUCILLE V. ABAD, Ph.D.</u> <small>CHIEF, ARD</small> <u>PRECIOSA CORAZON B. PABROA, Ph. D.</u> <small>CHIEF, NSD</small>	<u>ENGR. ARTURO F. SALIH</u> <small>SSRS / OIC-ESS</small> <u>VALLERIE ANN I. SAMSON, Ph. D.</u> <small>DEPUTY DIRECTOR</small>	<u>ENGR. C. PELMONTE</u> DATE:	M - 1 <small>PAGE NO. OF TOTAL NO. OF PAGES</small> 08 of 16

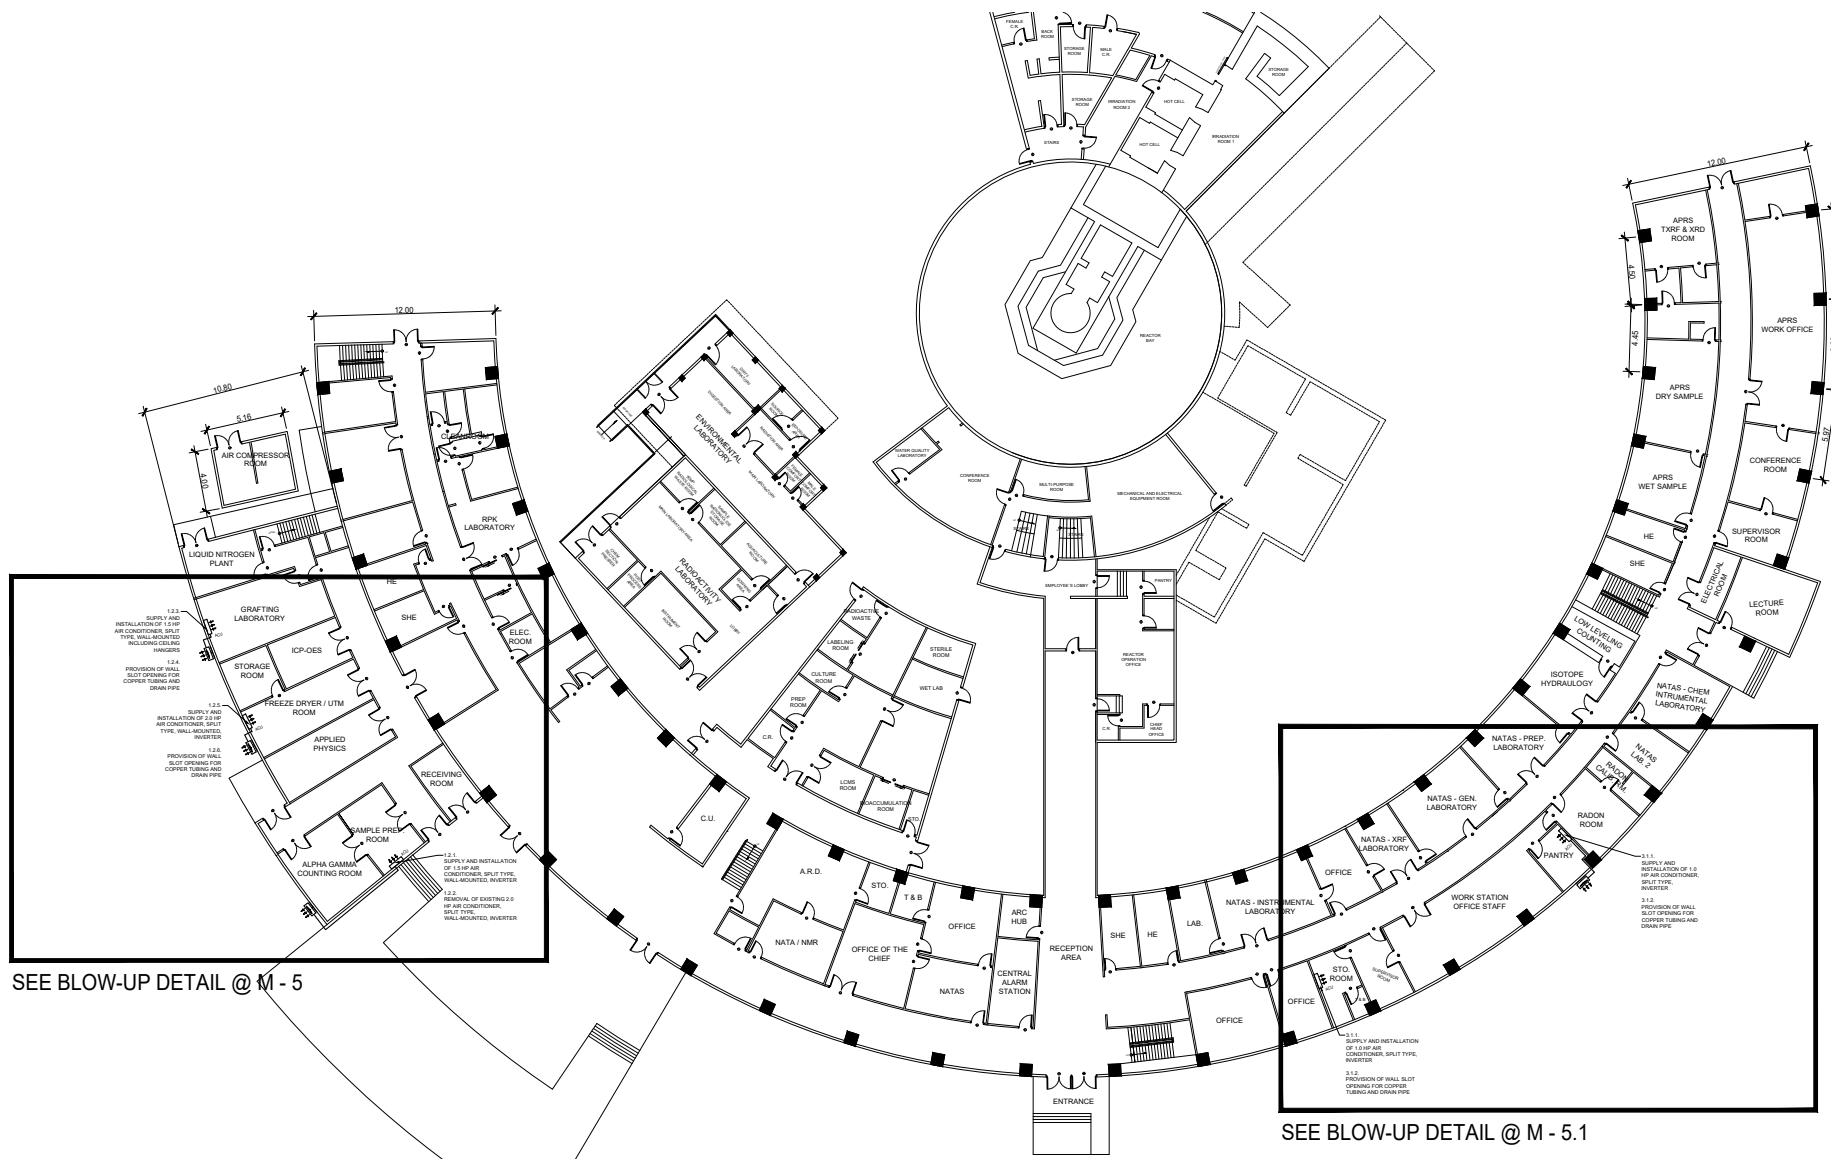

1 GROUND FLOOR
LOCATION OF AIR CONDITION UNITS
SCALE 1:500
M - 2



 <p>Republic of the Philippines DEPARTMENT OF SCIENCE AND TECHNOLOGY PHILIPPINE NUCLEAR RESEARCH INSTITUTE COMMONWEALTH AVENUE, DILIMAN, QUEZON CITY</p>	PROJECT TITLE:	SHEET CONTENT/S:	PREPARED BY:	RECOMMENDING APPROVALS:	APPROVED BY:	DRAWN BY:	SHEET NO.
	UPGRADING OF ARC BUILDING (C.Y. 2023) (DESIGN AND BUILD)	GROUND FLOOR LOCATION OF AIR CONDITION UNITS	ENGR. ROSALINO B. REJAS SSRS, ESS ENGR. ANDREW C. BARRIDA ENGINEER II, ESS	JORDAN MADRID, Ph.D. END-USER, HEAD CRS LUCILLE V. ABAD, Ph.D. CHIEF, ARD PRECIOSA CORAZON B. PABROA, Ph. D. CHIEF, NSD	ENGR. ARTURO F. SALIH SSRS / OIC-ESS VALLERIE ANN I. SAMSON, Ph. D. DEPUTY DIRECTOR	ENGR. C. PELMONTE DATE:	M - 2 PAGE NO. OF TOTAL NO. OF PAGES 09 of 16
						CARLO A. ARCILLA, Ph. D. DIRECTOR	

SEE BLOW-UP DETAIL @ M - 6

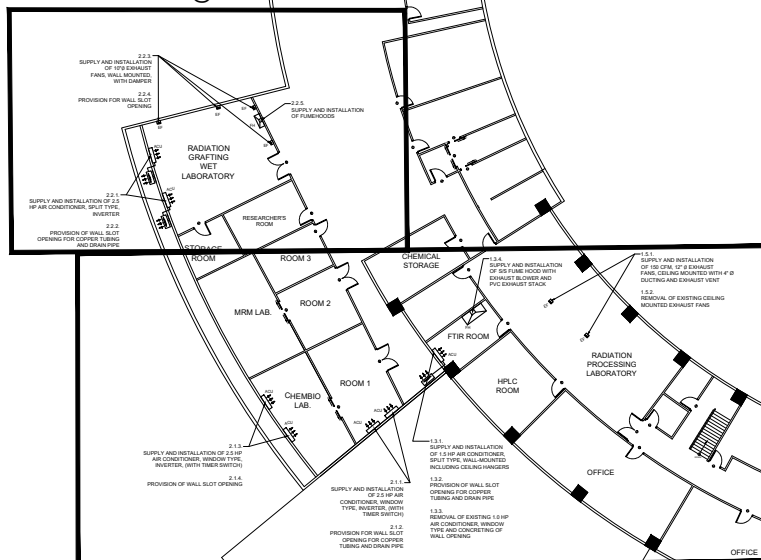


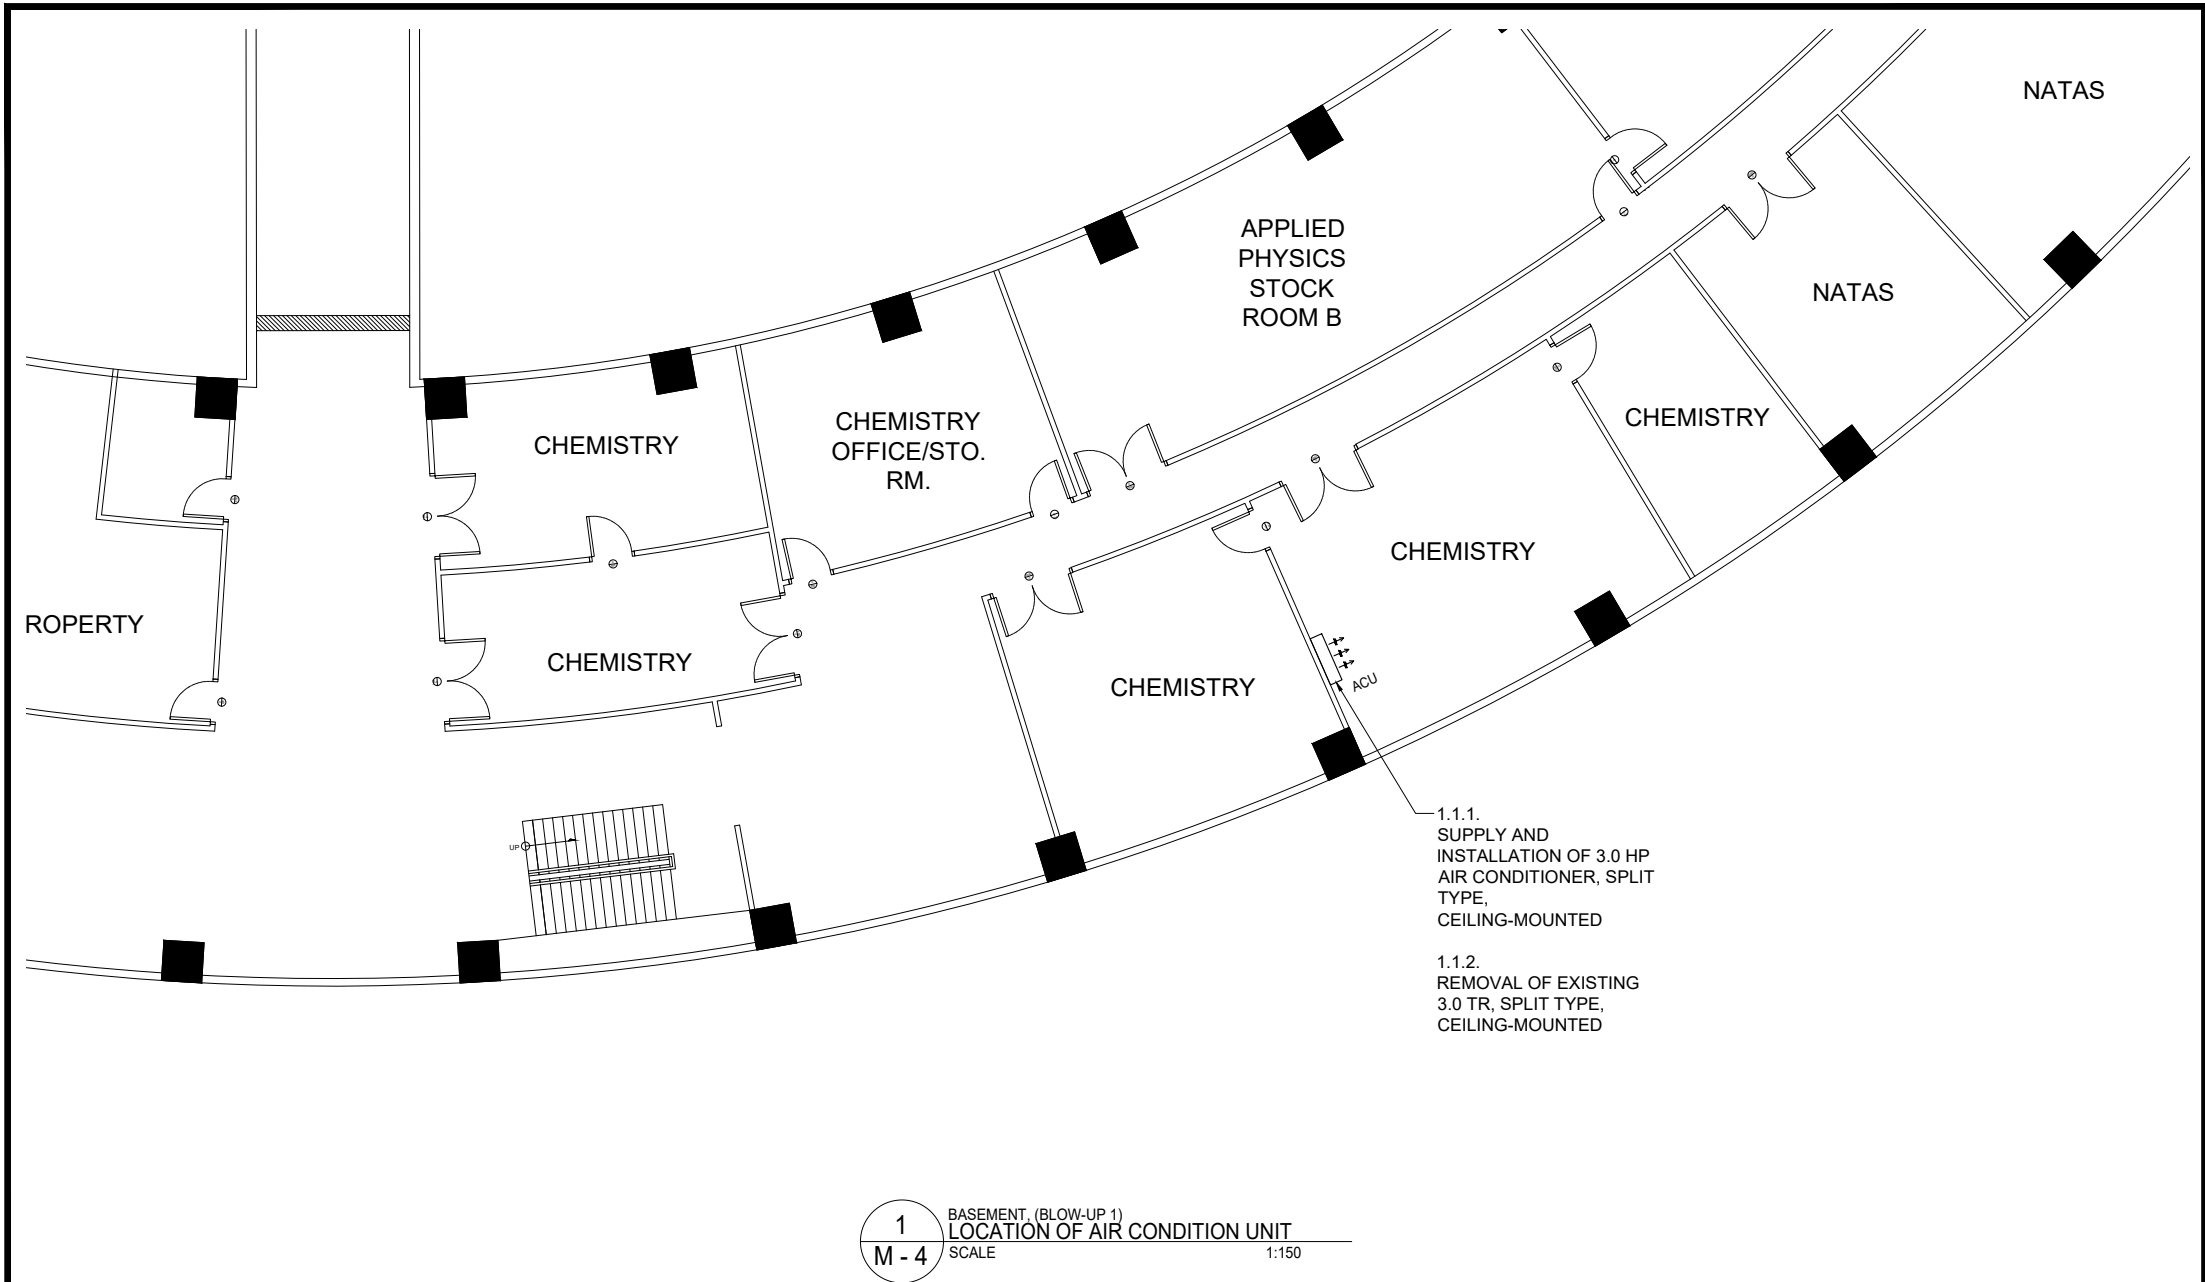
SEE BLOW-UP DETAIL @ M - 6.1

SEE BLOW-UP DETAIL @ M - 6.2

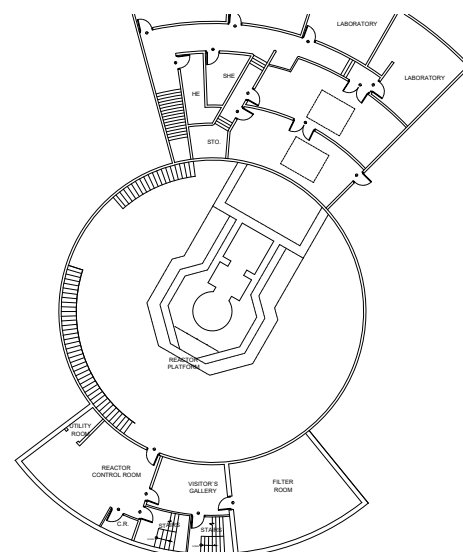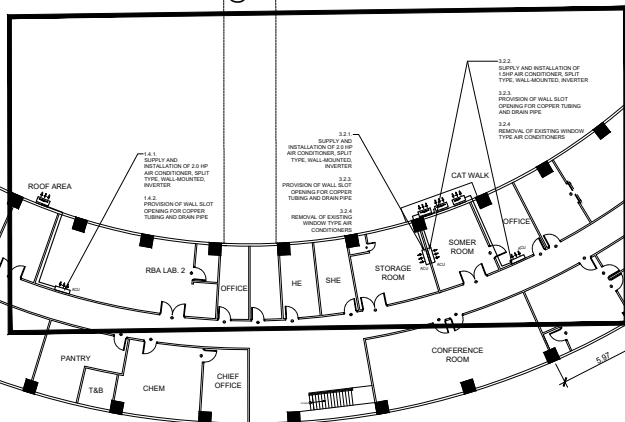


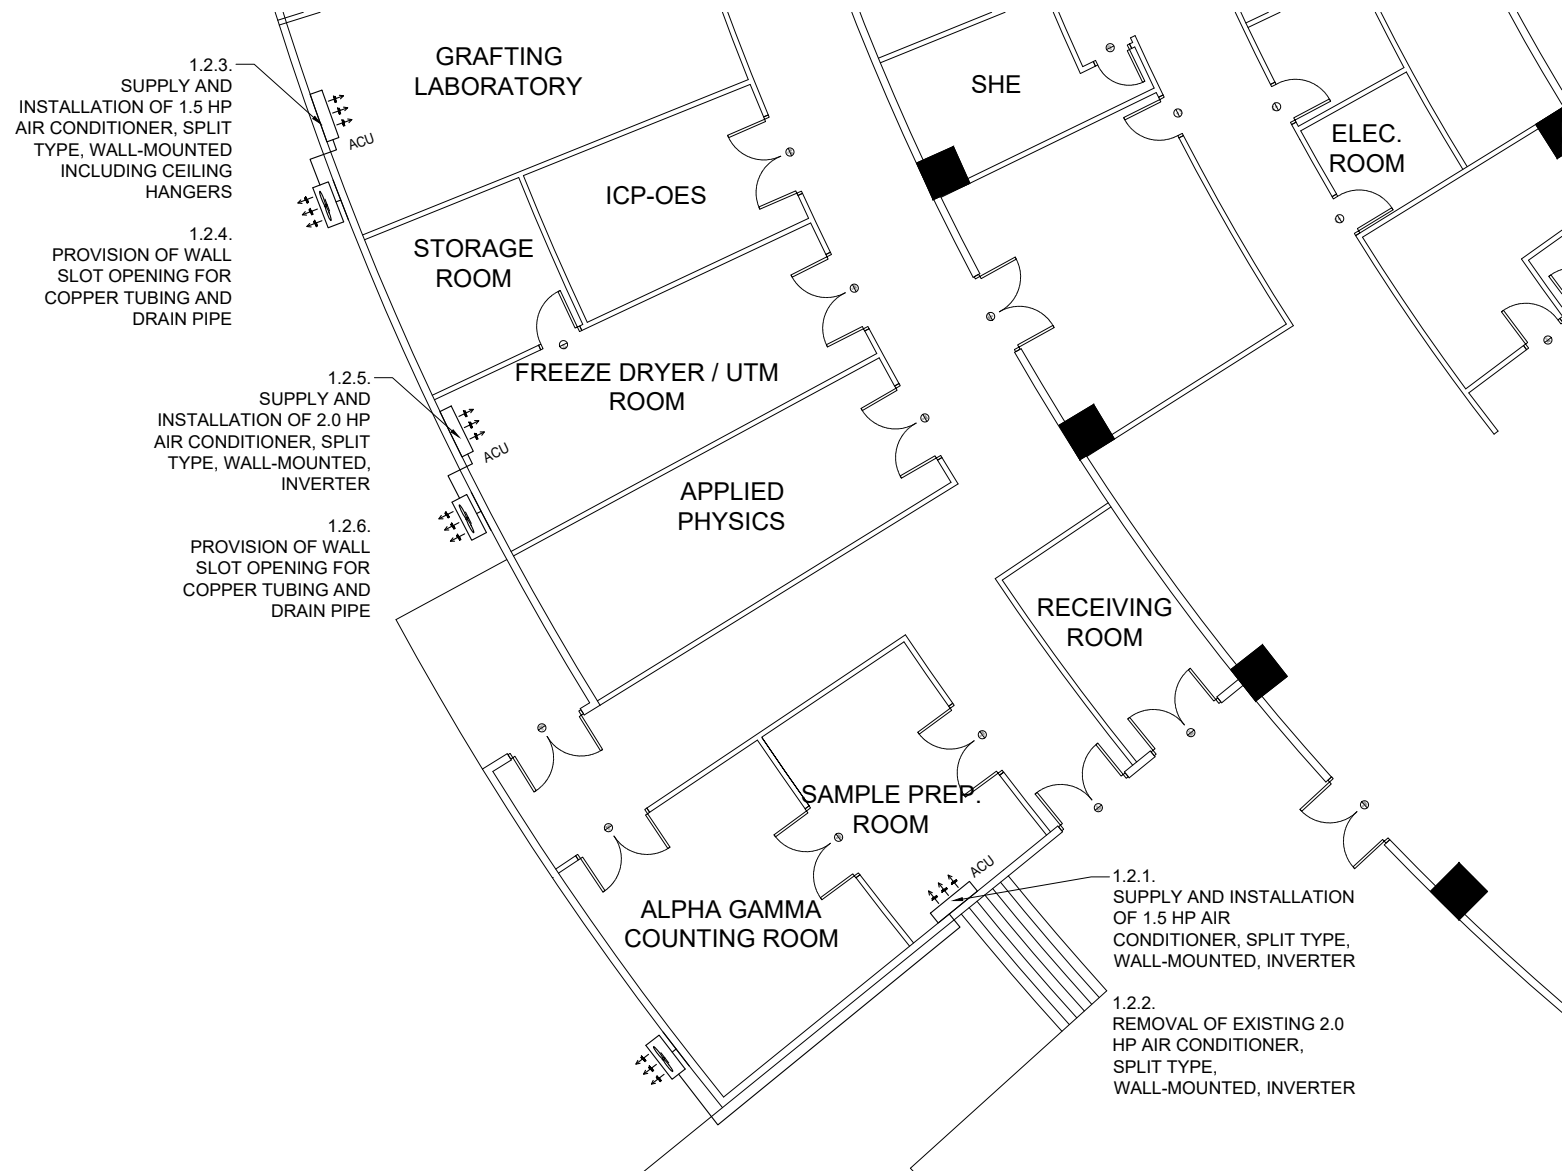
1 SECOND FLOOR
M - 3 LOCATION OF AIR CONDITION UNITS
SCALE 1:500

 <p>Republic of the Philippines DEPARTMENT OF SCIENCE AND TECHNOLOGY PHILIPPINE NUCLEAR RESEARCH INSTITUTE COMMONWEALTH AVENUE, DILIMAN, QUEZON CITY</p>	PROJECT TITLE:	SHEET CONTENT/S:	PREPARED BY:	RECOMMENDING APPROVALS:	APPROVED BY:	DRAWN BY:	SHEET NO.
	UPGRADING OF ARC BUILDING (C.Y. 2023) (DESIGN AND BUILD)	SECOND FLOOR LOCATION OF AIR CONDITION UNITS	ENGR. ROSALINO B. REJAS SSRS, ESS ENGR. ANDREW C. BARRIDA ENGINEER II, ESS	JORDAN MADRID, Ph.D. END-USER, HEAD CRS LUCILLE V. ABAD, Ph.D. CHIEF, ARD PRECIOSA CORAZON B. PABROA, Ph. D. CHIEF, NSD	ENGR. ARTURO F. SALIH SSRS / OIC-ESS CARLO A. ARCILLA, Ph. D. DIRECTOR	ENGR. C. PELMONTE DATE:	M - 3 PAGE NO. OF TOTAL NO. OF PAGES 10 of 16




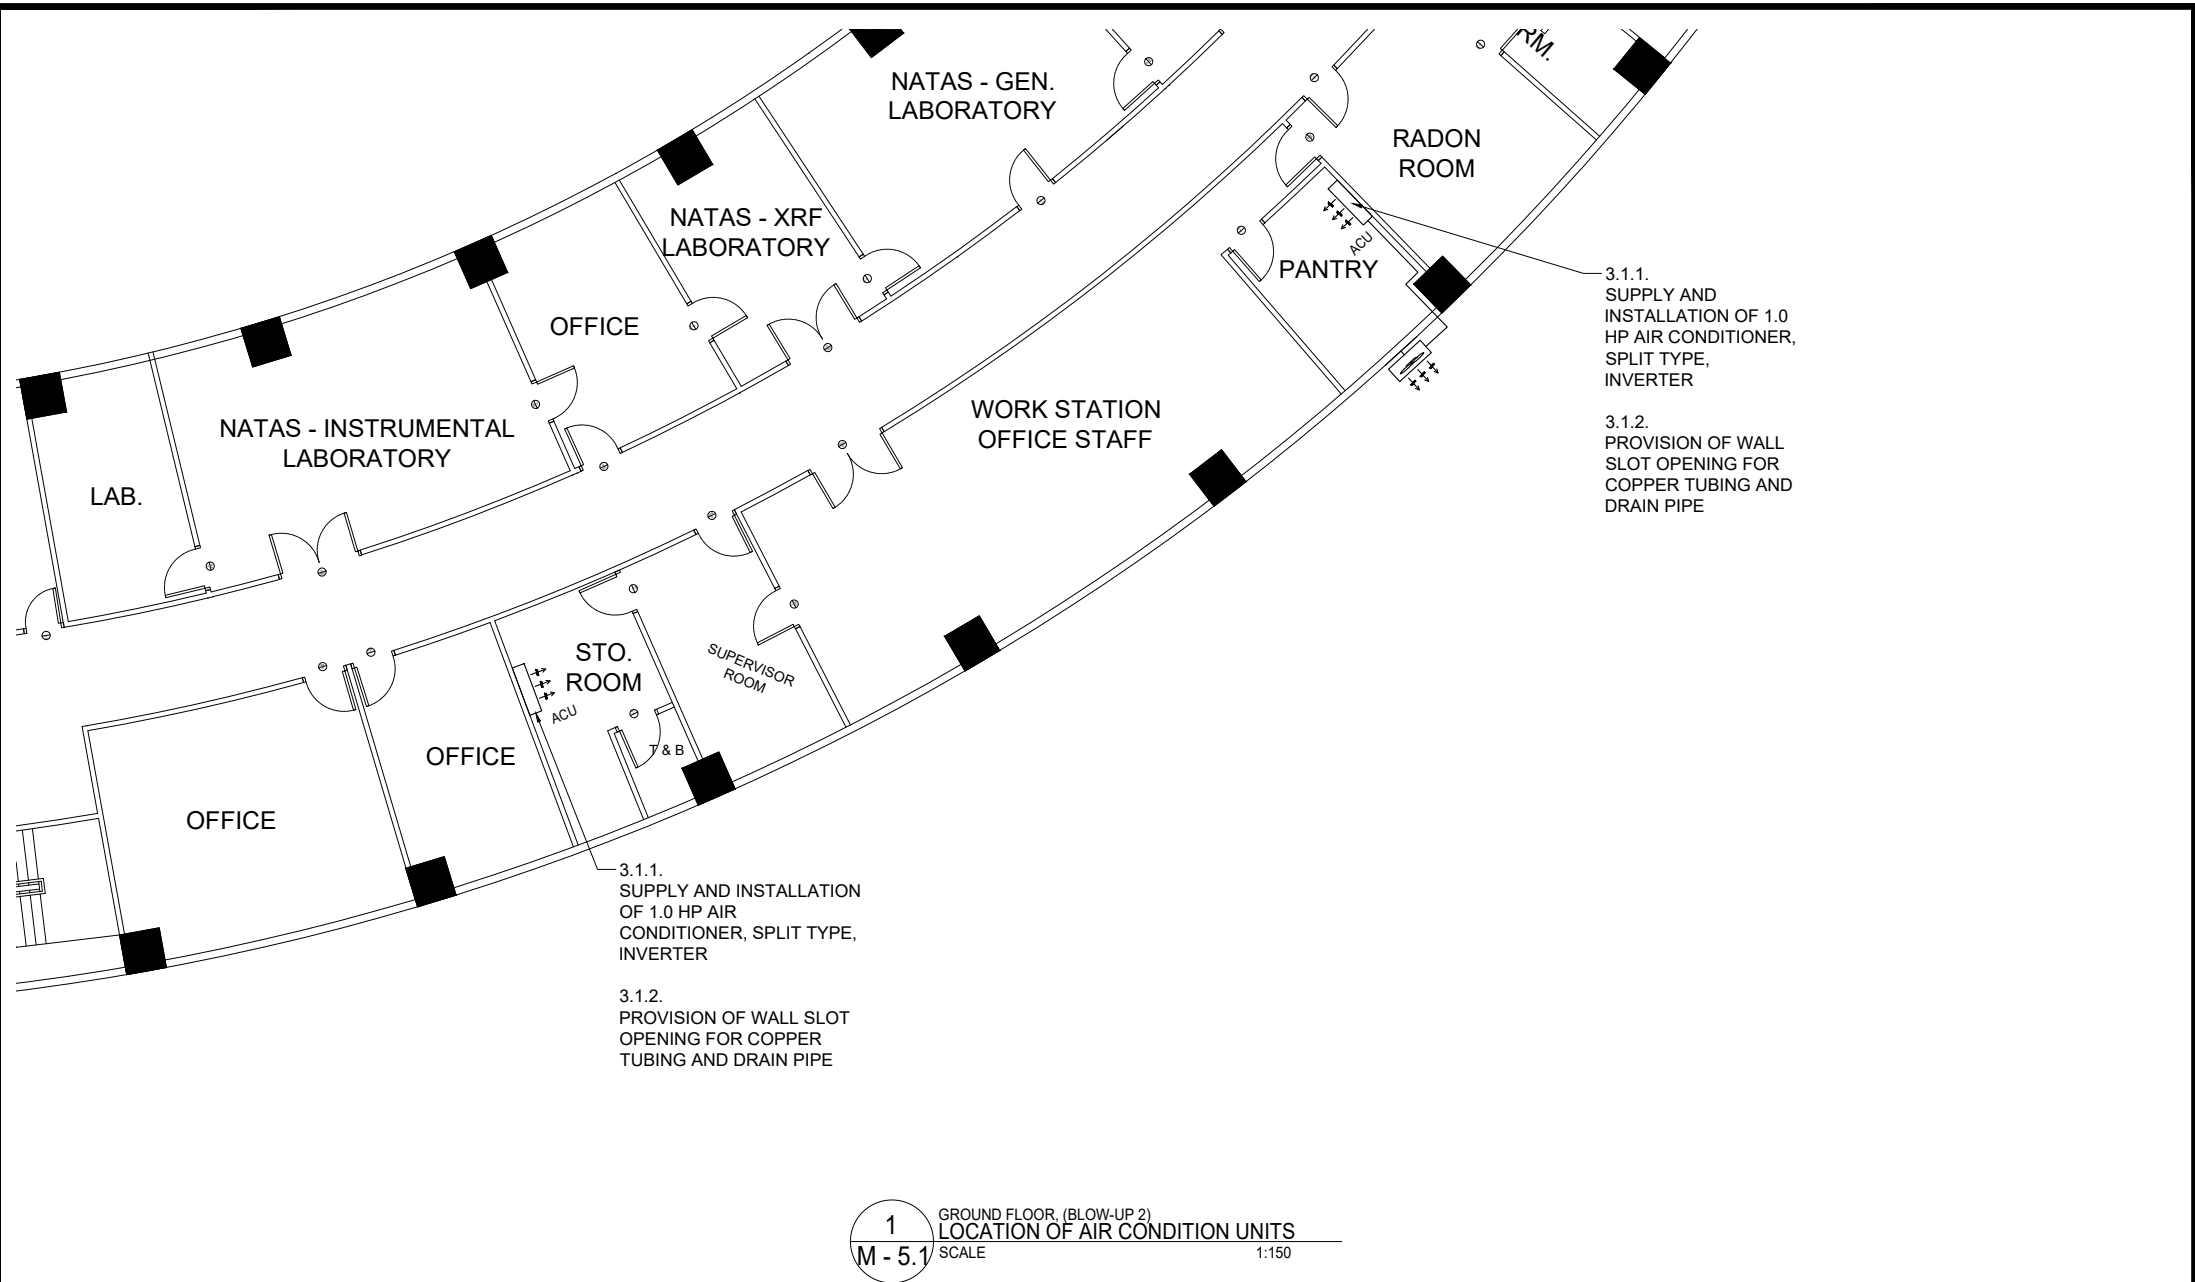
1 BASEMENT, (BLOW-UP 1)
 LOCATION OF AIR CONDITION UNIT
 M - 4 SCALE 1:150

 <p>Republic of the Philippines DEPARTMENT OF SCIENCE AND TECHNOLOGY PHILIPPINE NUCLEAR RESEARCH INSTITUTE COMMONWEALTH AVENUE, DILIMAN, QUEZON CITY</p>	PROJECT TITLE:	SHEET CONTENT/S:	PREPARED BY:	RECOMMENDING APPROVALS:	APPROVED BY:	DRAWN BY:	SHEET NO.
	UPGRADING OF ARC BUILDING (C.Y. 2023) (DESIGN AND BUILD)	BASEMENT, (BLOW-UP 1) LOCATION OF AIR CONDITION UNIT	ENGR. ROSALINO B. REJAS SSRS, ESS ENGR. ANDREW C. BARRIDA ENGINEER II, ESS	JORDAN MADRID, Ph.D. END-USER, HEAD CRS LUCILLE V. ABAD, Ph.D. CHIEF, ARD PRECIOSA CORAZON B. PABROA, Ph. D. CHIEF, NSD	ENGR. ARTURO F. SALIH SSRS / OIC-ESS VALLERIE ANN I. SAMSON, Ph. D. DEPUTY DIRECTOR	ENGR. C. PELMONTE DATE:	M - 4
						CARLO A. ARCILLA, Ph. D. DIRECTOR	PAGE NO. OF TOTAL NO. OF PAGES
							11 of 16

 



1 GROUND FLOOR, (BLOW-UP 1)
 M - 5 LOCATION OF AIR CONDITION UNITS
 SCALE 1:150


 <p>Republic of the Philippines DEPARTMENT OF SCIENCE AND TECHNOLOGY PHILIPPINE NUCLEAR RESEARCH INSTITUTE COMMONWEALTH AVENUE, DILIMAN, QUEZON CITY</p>	PROJECT TITLE:	SHEET CONTENT/S:	PREPARED BY:	RECOMMENDING APPROVALS:	APPROVED BY:	DRAWN BY:	SHEET NO.
	UPGRADING OF ARC BUILDING (C.Y. 2023) (DESIGN AND BUILD)	GROUND FLOOR, (BLOW-UP 1)	ENGR. ROSALINO B. REJAS SSRS, ESS	JORDAN MADRID, Ph.D. END-USER, HEAD CRS LUCILLE V. ABAD, Ph.D. CHIEF, ARD	ENGR. ARTURO F. SALIH SSRS / OIC-ESS	ENGR. C. PELMONTE	M - 5
	LOCATION OF AIR CONDITION UNITS	ENGR. ANDREW C. BARRIDA ENGINEER II, ESS	PRECIOSA CORAZON B. PABROA, Ph. D. CHIEF, NSD	VALLERIE ANN I. SAMSON, Ph. D. DEPUTY DIRECTOR	CARLO A. ARCILLA, Ph. D. DIRECTOR	DATE:	PAGE NO. OF TOTAL NO. OF PAGES 12 of 16





1 GROUND FLOOR, (BLOW-UP 2)
 LOCATION OF AIR CONDITION UNITS
 M - 5.1 SCALE 1:150


 <p>Republic of the Philippines DEPARTMENT OF SCIENCE AND TECHNOLOGY PHILIPPINE NUCLEAR RESEARCH INSTITUTE COMMONWEALTH AVENUE, DILIMAN, QUEZON CITY</p>	PROJECT TITLE:	SHEET CONTENT/S:	PREPARED BY:	RECOMMENDING APPROVALS:	APPROVED BY:	DRAWN BY:	SHEET NO.
	UPGRADING OF ARC BUILDING (C.Y. 2023) (DESIGN AND BUILD)	GROUND FLOOR, (BLOW-UP 2)	ENGR. ROSALINO B. REJAS SSRS, ESS	JORDAN MADRID, Ph.D. END-USER, HEAD CRS LUCILLE V. ABAD, Ph.D. CHIEF, ARD	ENGR. ARTURO F. SALIH SSRS / OIC-ESS	ENGR. C. PELMONTE	M - 5.1
	LOCATION OF AIR CONDITION UNITS	ENGR. ANDREW C. BARRIDA ENGINEER II, ESS	PRECIOSA CORAZON B. PABROA, Ph. D. CHIEF, NSD	VALLERIE ANN I. SAMSON, Ph. D. DEPUTY DIRECTOR	CARLO A. ARCILLA, Ph. D. DIRECTOR	DATE:	PAGE NO. OF TOTAL NO. OF PAGES
							13 of 16

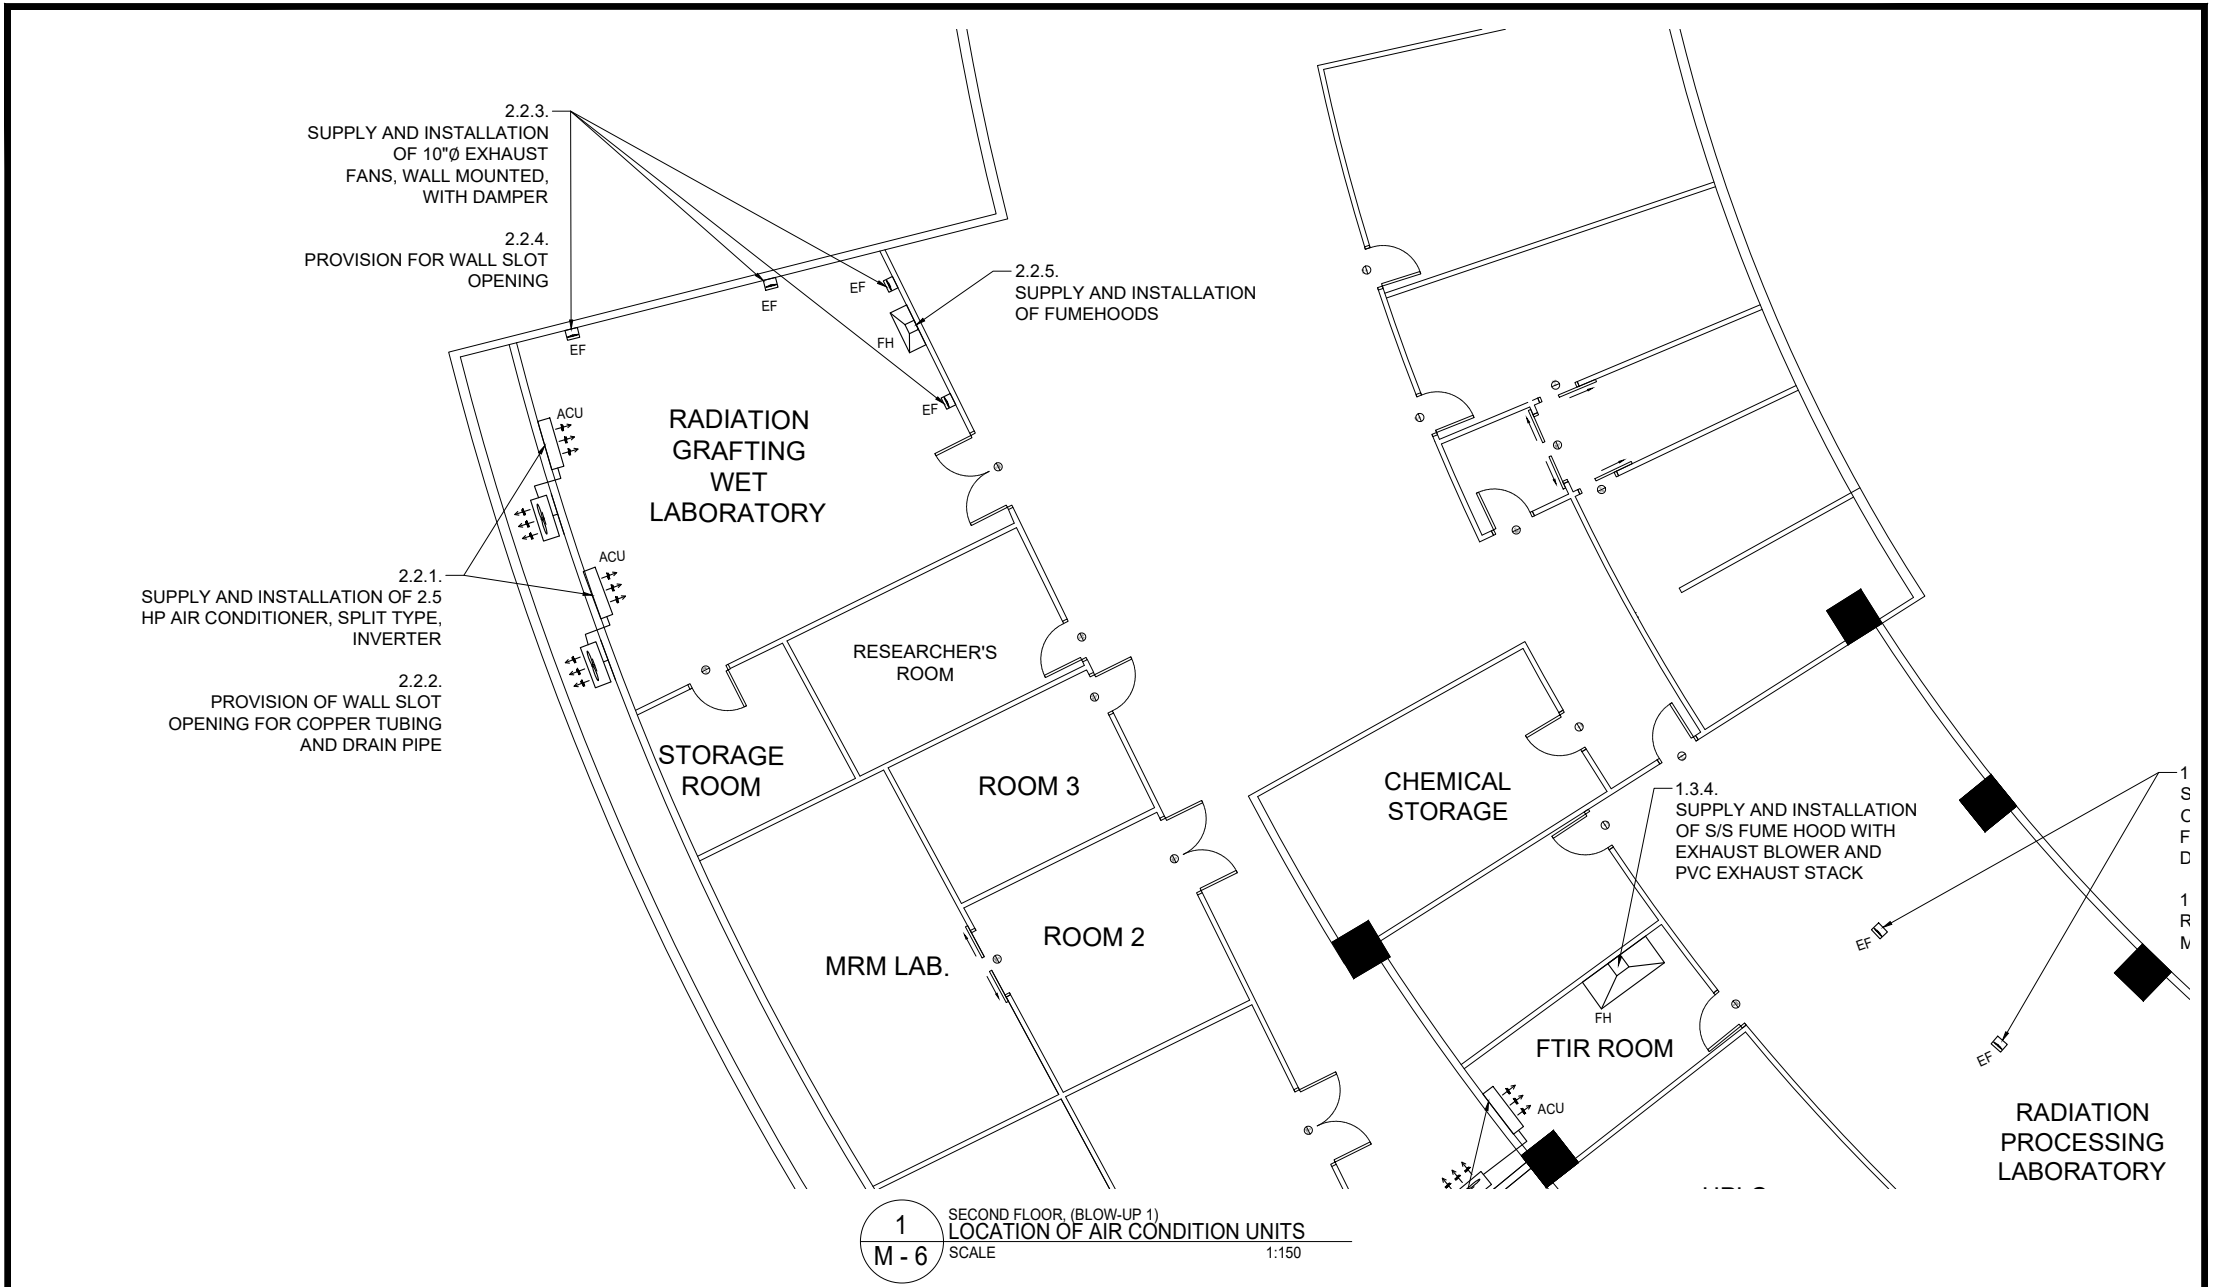


 <p>Republic of the Philippines DEPARTMENT OF SCIENCE AND TECHNOLOGY PHILIPPINE NUCLEAR RESEARCH INSTITUTE COMMONWEALTH AVENUE, DILIMAN, QUEZON CITY</p>	PROJECT TITLE:	SHEET CONTENT/S:	PREPARED BY:	RECOMMENDING APPROVALS:	APPROVED BY:	DRAWN BY:	SHEET NO.
	UPGRADING OF ARC BUILDING (C.Y. 2023) (DESIGN AND BUILD)	SECOND FLOOR, (BLOW-UP 1)	ENGR. ROSALINO B. REJAS SSRS, ESS	JORDAN MADRID, Ph.D. END-USER, HEAD CRS LUCILLE V. ABAD, Ph.D. CHIEF, ARD	ENGR. ARTURO F. SALIH SSRS / OIC-ESS	ENGR. C. PELMONTE	M - 6
	LOCATION OF AIR CONDITION UNITS	ENGR. ANDREW C. BARRIDA ENGINEER II, ESS	PRECIOSA CORAZON B. PABROA, Ph. D. CHIEF, NSD	VALLERIE ANN I. SAMSON, Ph. D. DEPUTY DIRECTOR	CARLO A. ARCILLA, Ph. D. DIRECTOR	DATE:	PAGE NO. OF TOTAL NO. OF PAGES
							14 of 16

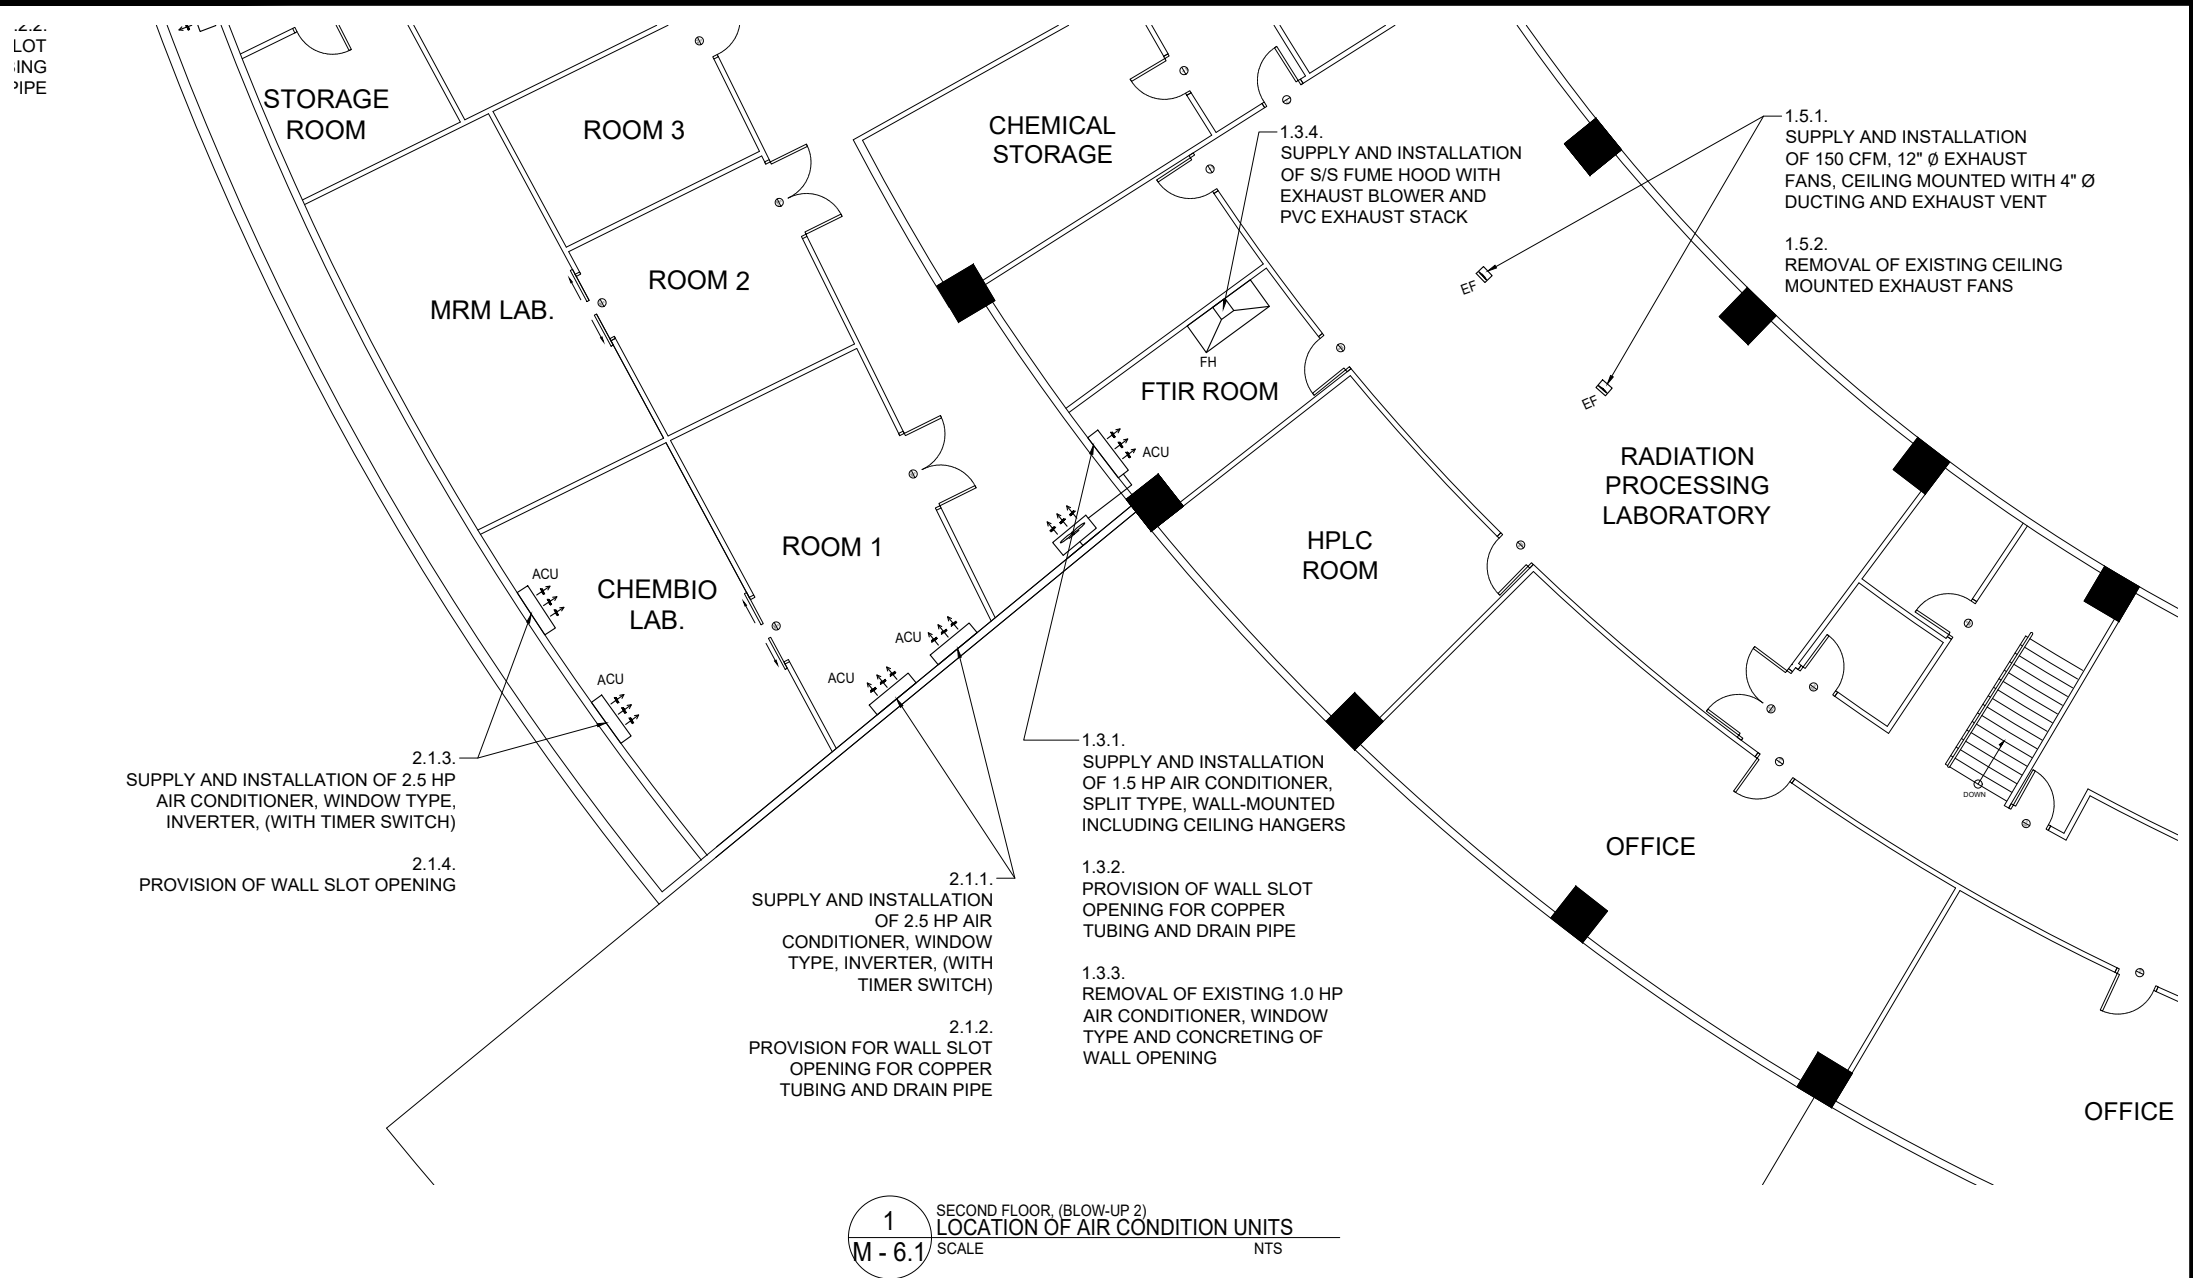

 <p>Republic of the Philippines DEPARTMENT OF SCIENCE AND TECHNOLOGY PHILIPPINE NUCLEAR RESEARCH INSTITUTE COMMONWEALTH AVENUE, DILIMAN, QUEZON CITY</p>	PROJECT TITLE:	SHEET CONTENT/S:	PREPARED BY:	RECOMMENDING APPROVALS:	APPROVED BY:	DRAWN BY:	SHEET NO.	
	UPGRADING OF ARC BUILDING (C.Y. 2023) (DESIGN AND BUILD)	SECOND FLOOR, (BLOW-UP 2)	ENGR. ROSALINO B. REJAS SSRS, ESS	JORDAN MADRID, Ph.D. END-USER, HEAD CRS LUCILLE V. ABAD, Ph.D. CHIEF, ARD	ENGR. ARTURO F. SALIH SSRS / OIC-ESS	ENGR. C. PELMONTE	M - 6.1	
	LOCATION OF AIR CONDITION UNITS		ENGR. ANDREW C. BARRIDA ENGINEER II, ESS	PRECIOSA CORAZON B. PABROA, Ph. D. CHIEF, NSD	VALLERIE ANN I. SAMSON, Ph. D. DEPUTY DIRECTOR	CARLO A. ARCILLA, Ph. D. DIRECTOR	DATE:	PAGE NO. OF TOTAL NO. OF PAGES 15 of 16

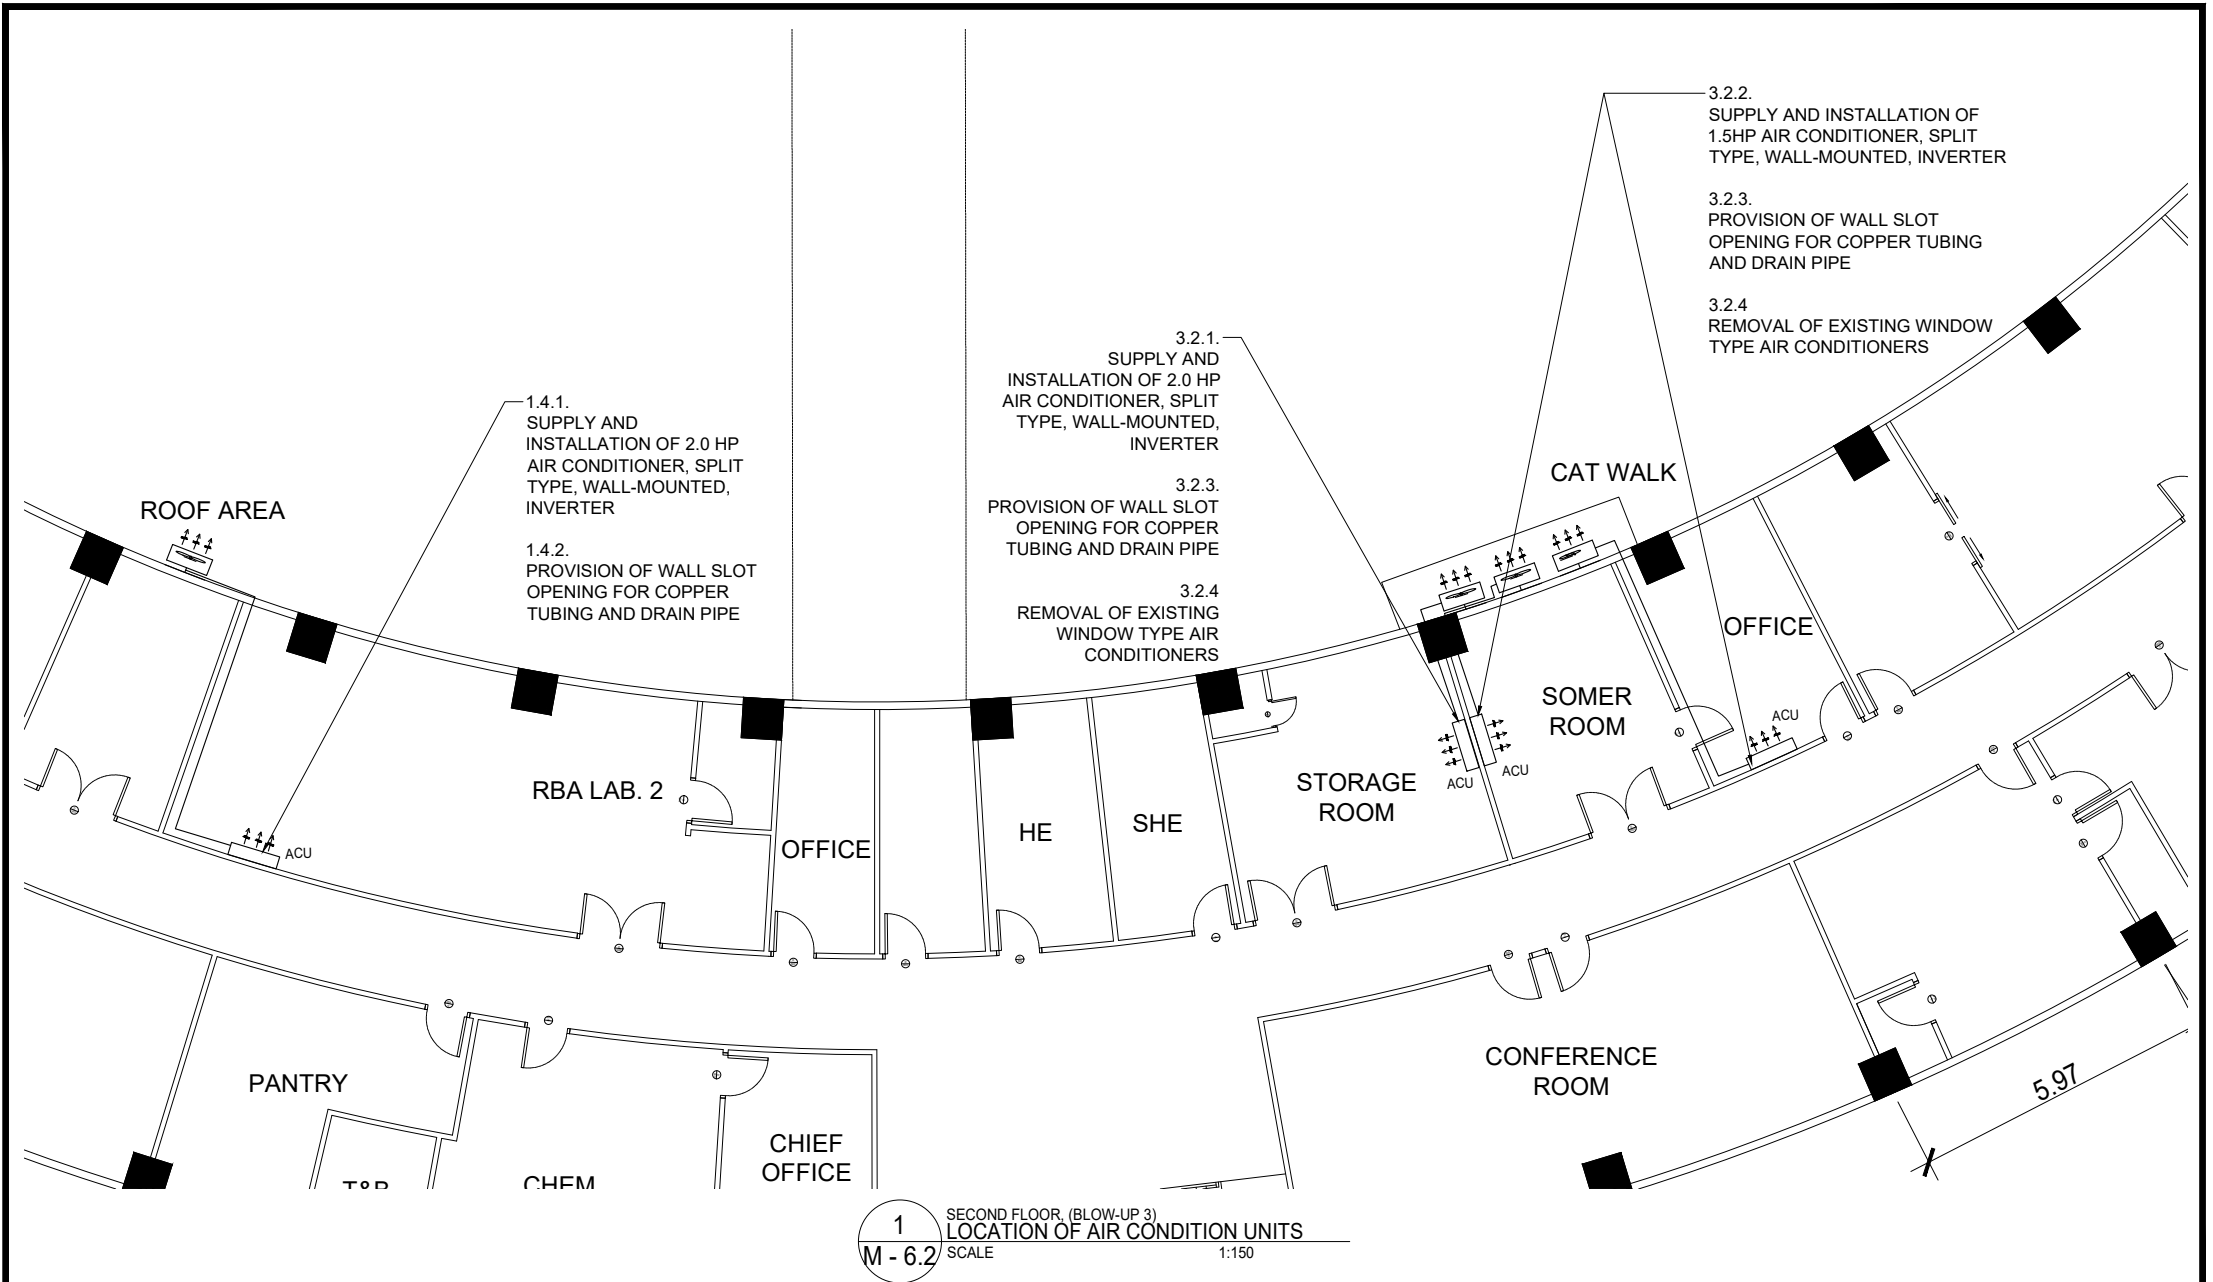

1 SECOND FLOOR, (BLOW-UP 3)
 LOCATION OF AIR CONDITION UNITS
 M - 6.2 SCALE 1:150

 <p>Republic of the Philippines DEPARTMENT OF SCIENCE AND TECHNOLOGY PHILIPPINE NUCLEAR RESEARCH INSTITUTE COMMONWEALTH AVENUE, DILIMAN, QUEZON CITY</p>	PROJECT TITLE:	SHEET CONTENT/S:	PREPARED BY:	RECOMMENDING APPROVALS:	APPROVED BY:	DRAWN BY:	SHEET NO.	
	UPGRADING OF ARC BUILDING (C.Y. 2023) (DESIGN AND BUILD)	SECOND FLOOR, (BLOW-UP 3) LOCATION OF AIR CONDITION UNITS	ENGR. ROSALINO B. REJAS SSRS, ESS ENGR. ANDREW C. BARRIDA ENGINEER II, ESS	JORDAN MADRID, Ph.D. END-USER, HEAD CRS LUCILLE V. ABAD, Ph.D. CHIEF, ARD PRECIOSA CORAZON B. PABROA, Ph. D. CHIEF, NSD	ENGR. ARTURO F. SALIH SSRS / OIC-ESS VALLERIE ANN I. SAMSON, Ph. D. DEPUTY DIRECTOR	CARLO A. ARCILLA, Ph. D. DIRECTOR	ENGR. C. PELMONTE DATE:	M - 6.2 PAGE NO. OF TOTAL NO. OF PAGES 16 of 16